
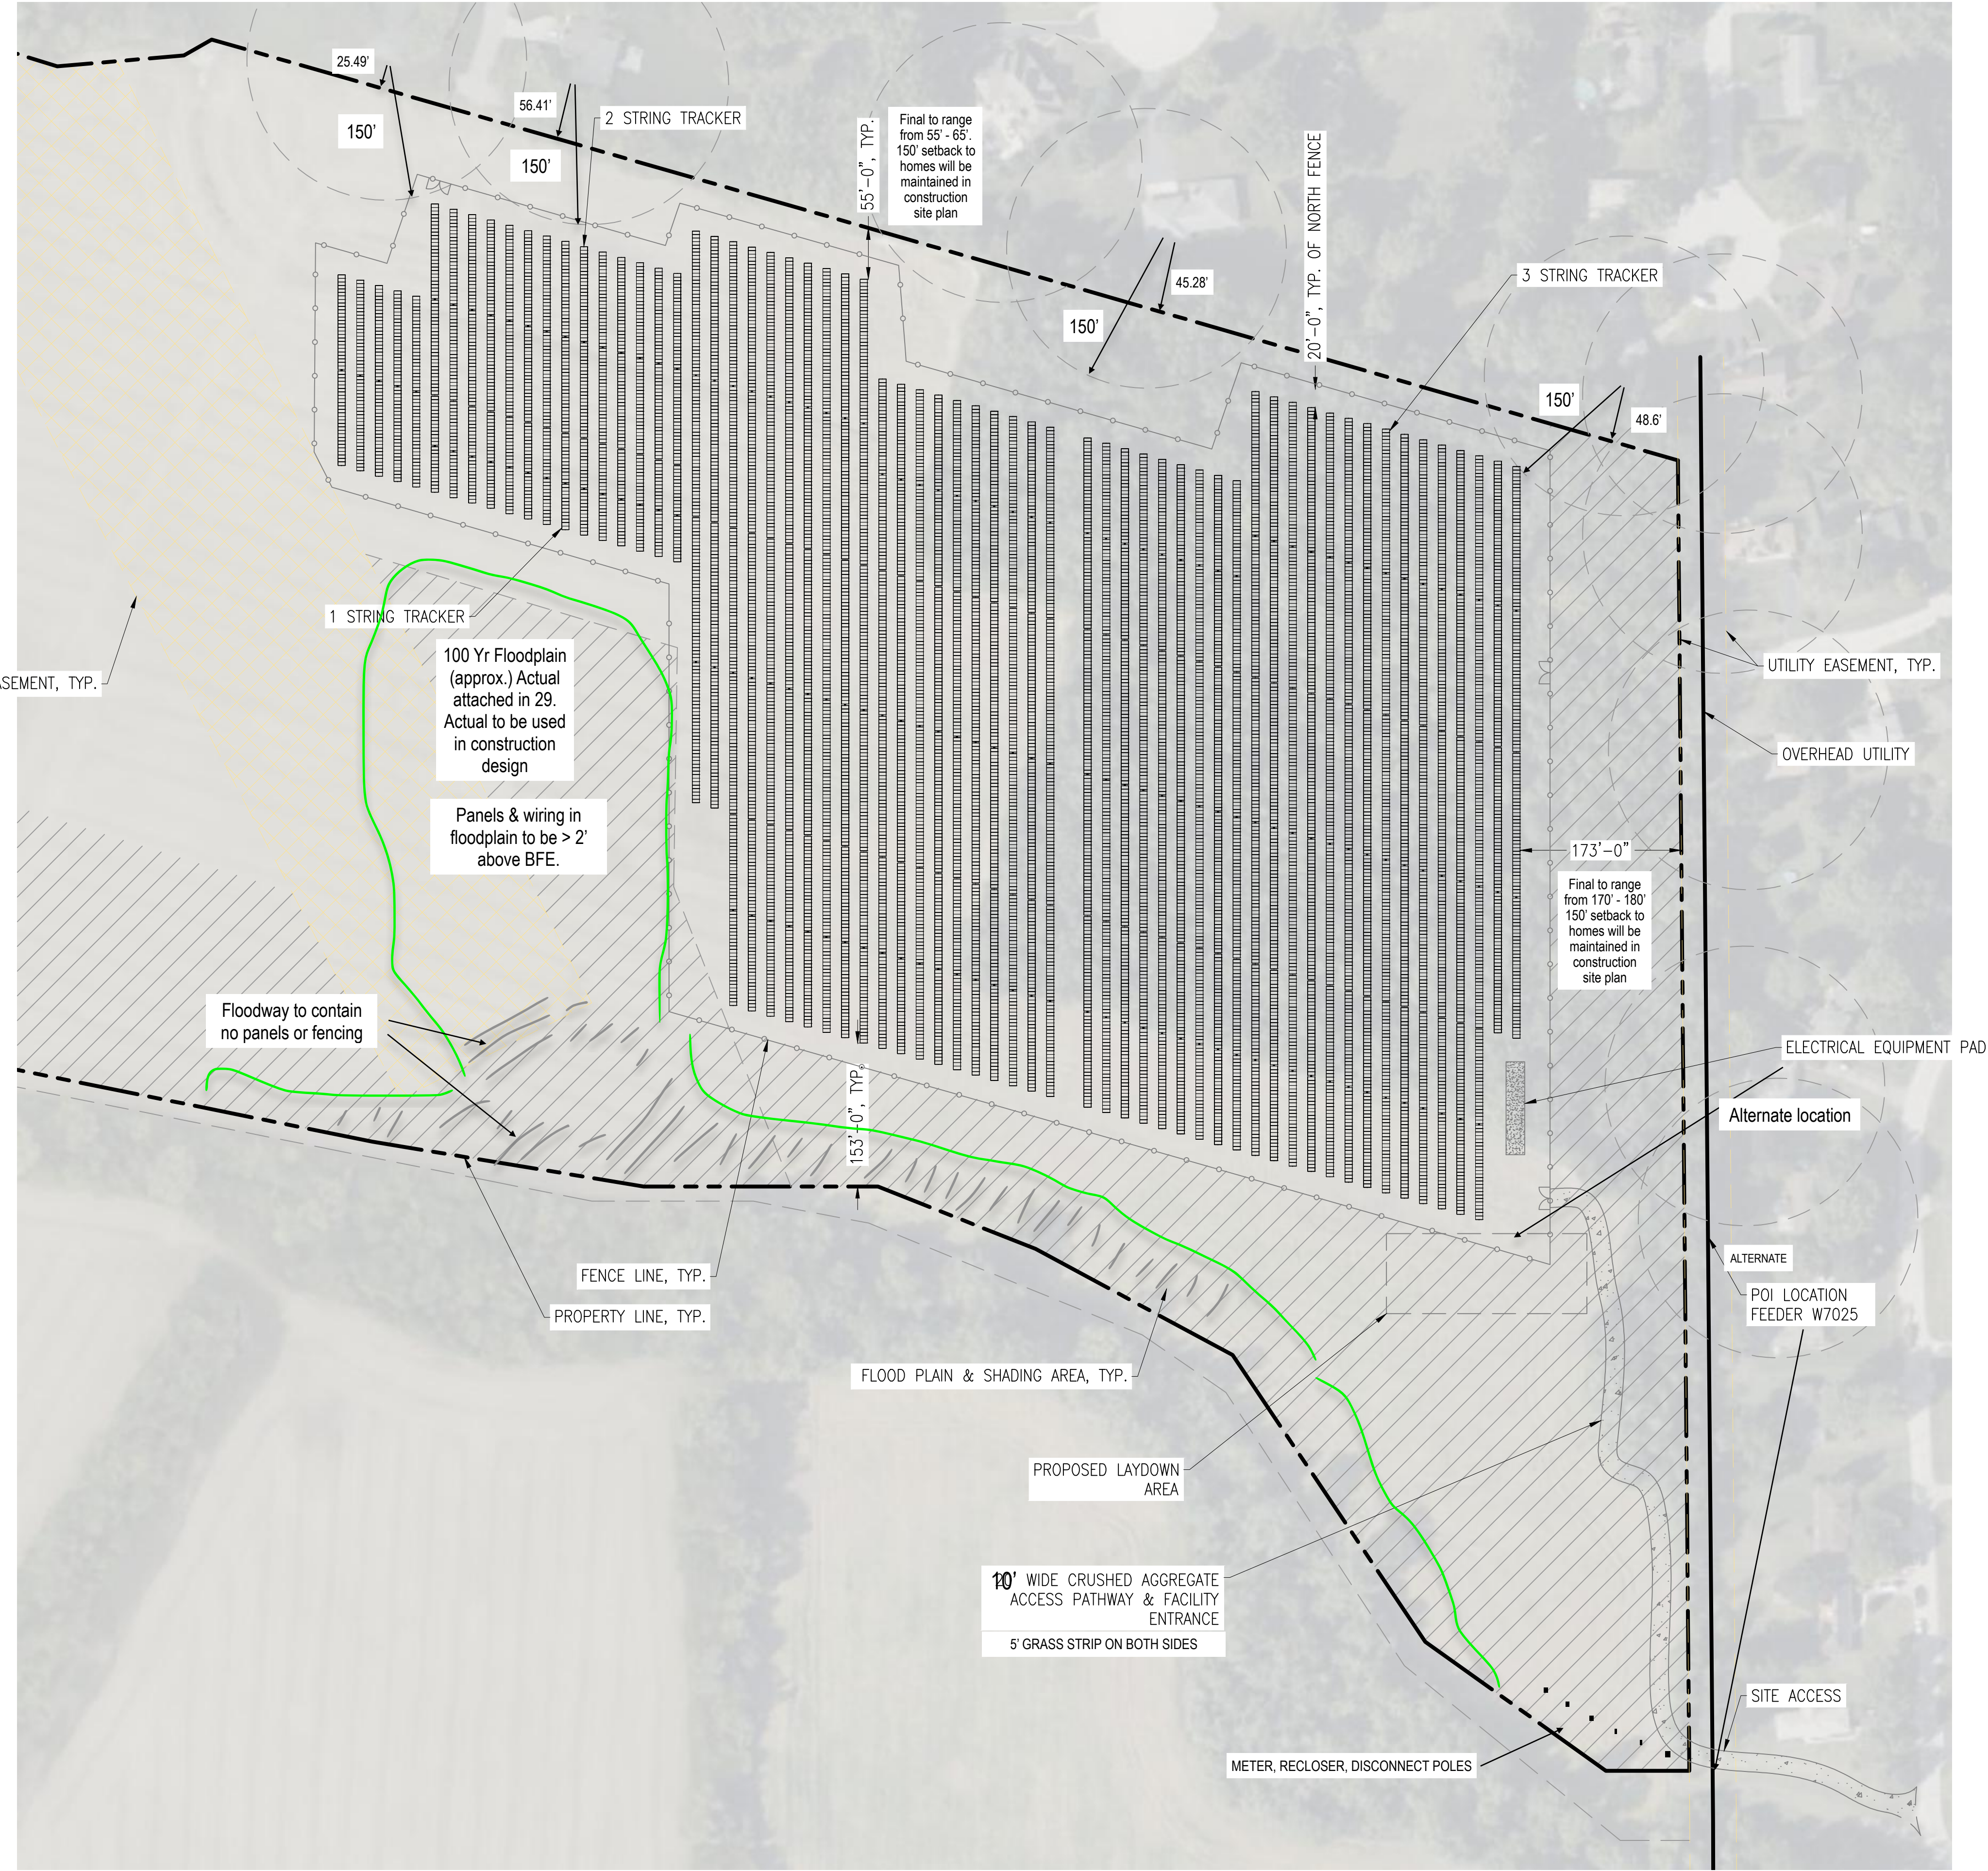


C:\Users\jared.pantogva\Documents\Projects\Trina Solar\1. CAD Drawings\Equity Advisors_VFP_v02.dwg

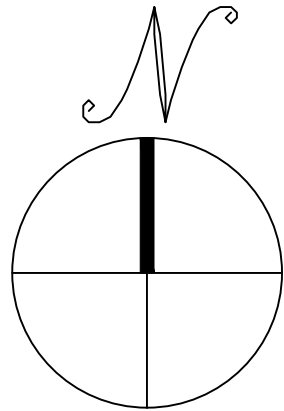

SITE PLAN

SCALE: 1" = 100'

0 100' 200'

SHEET NOTES

1. LAYOUT AND FINAL EMBEDMENT DEPTH SUBJECT TO CHANGE UPON RECEIPT OF CIVIL AND GEOTECHNICAL REPORTS

SYSTEM SPECIFICATIONS	
DC SYSTEM SIZE (kW)	6,209.19
AC SYSTEM SIZE (kW)	5,000.00
DC/AC RATIO	1.24
TRACKER MAKE / MODEL	TRINA VANGUARD 1P
MODULE QTY. & MODEL	(10,179) TSM-NEG19RC.20
MODULE DC RATING (W)	610
MODULES PER STRING	27
GCR	39.1%
STRINGS	377
INVERTER QTY. & MODEL	(20) SOLECTRIA XGI 1500-250-600
INVERTER RATING (KVA)	250
TILT	+/- 60°
AZIMUTH	90° / 270°

THIS DOCUMENT IS PROVIDED BY TRINA SOLAR TO FACILITATE THE SALE AND/OR INSTALLATION OF A SOLAR POWER SYSTEM. REPRODUCTION, RELEASE OR UTILIZATION FOR ANY OTHER PURPOSE, WITHOUT PRIOR WRITTEN CONSENT IS STRICTLY PROHIBITED.

Trinasolar

7100 STEVENSON BLVD
FREMONT, CA 94538
PHONE: (800) 698-7114
WWW.TRINASOLAR.COM

NOT FOR
CONSTRUCTION

TNT HOWARD LLC
SOLAR ELECTRIC SYSTEM
ELGIN, IL

PROJECT NUMBER:
N/A

REV	DATE	DRAWN	CHECKED	RELEASE LEVEL
	10/09/24	JEP	N/A	PRELIMINARY
	11/08/24	JEP	N/A	PRELIMINARY REV01
	12/16/24	JEP	N/A	PRELIMINARY REV10

SCALES STATED ON DRAWINGS
ARE VALID ONLY WHEN PLOTTED
ARCH D 24" X 36"

PV-2
SITE PLAN